

STUDIO A

Operation Department.
Camera and Lighting Section


Studio Dimensions

Structure Dimensions:
(L: 14m, W: 11.8m, H: 8m)

Effective Dimensions:
(L: 12.2m, W: 10m, H: 6m)

Drawn By: Hesham Alyaseen.

Date: 06/12/2023

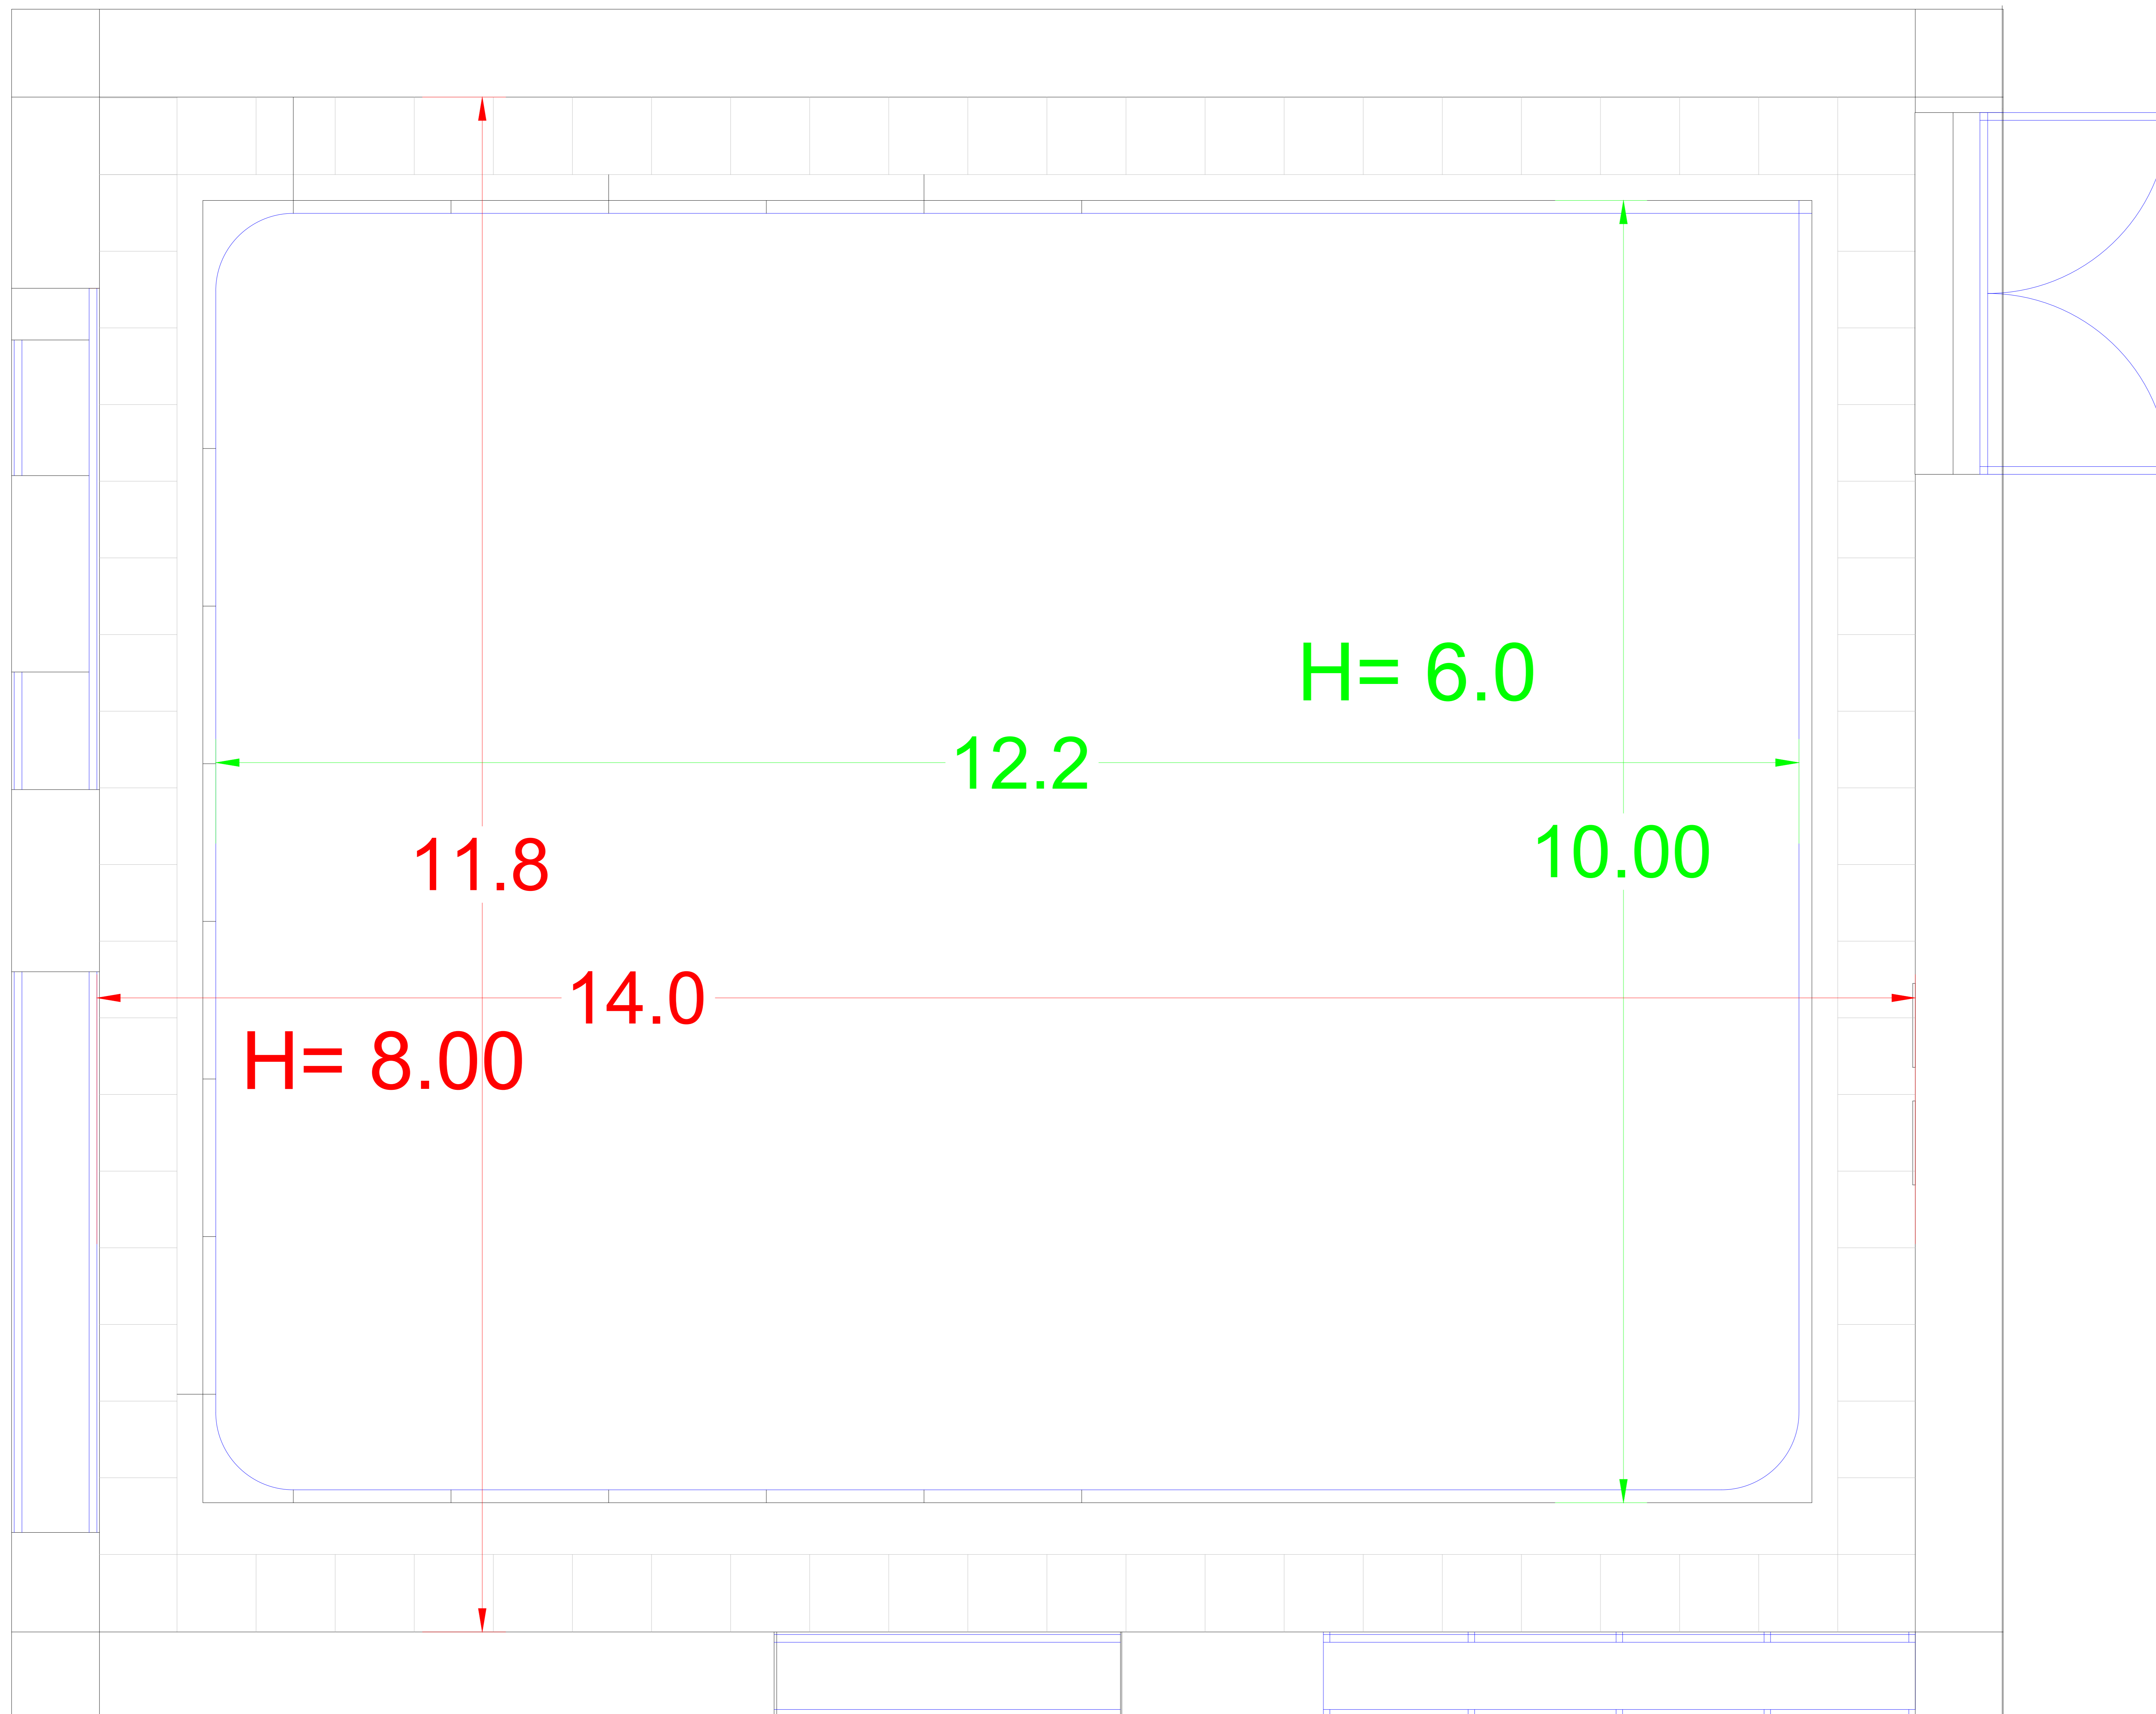

STUDIO A


Operation Department.
Camera and Lighting Section

Lighting Grid Layout

3*4 Beams

Drawn By: Hesham Alyaseen.

Date: 06/12/2023

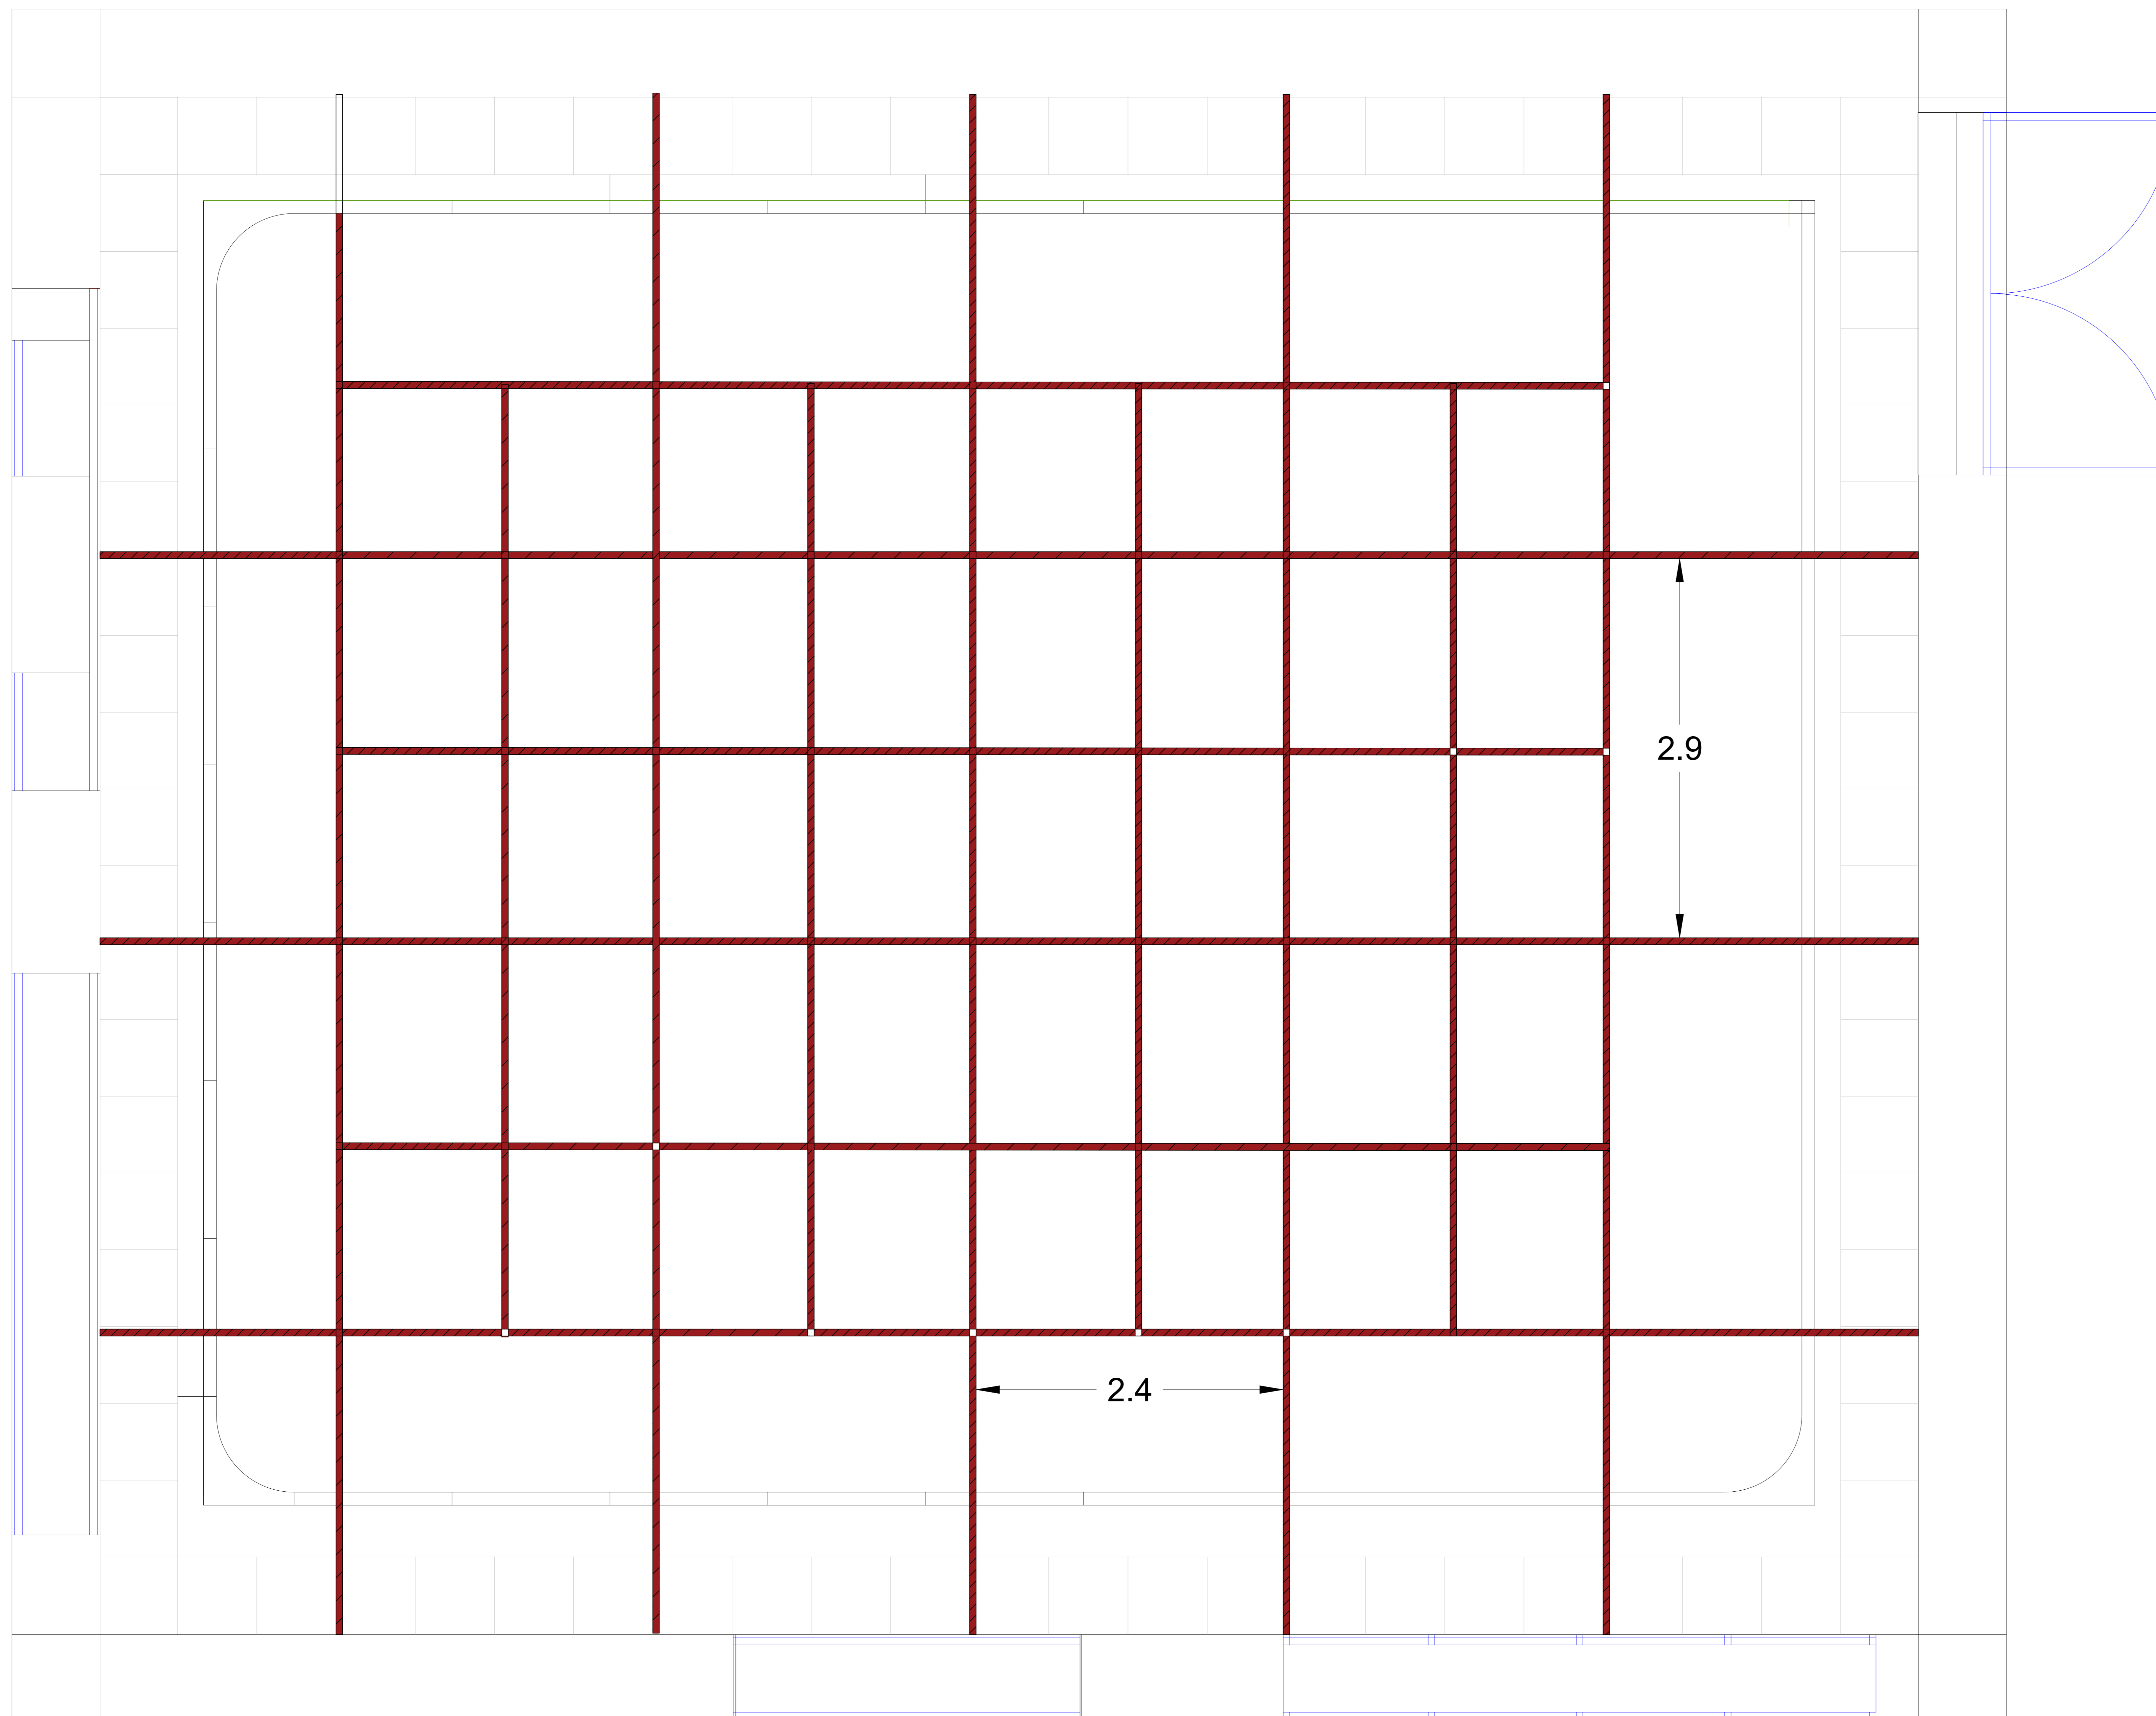



STUDIO A
Operation Department. Camera and Lighting Section
Power Layout
Floor level Panels
Ceiling Level Plugs Panels
SP: Single Phase TP: Three Phase
Drawn By: Hesham Alyaseen.
Date: 06/12/2023

